

K-800A/B
AIR COMPRESSOR
 MAKE: GARDNER DENVER
 MODEL: LI5-130
 129 m³/hr @ 896 kPag
 MAWP: 1600 kPag
 S/N (A): D096660
 S/N (B): D096650

KM-800A/B
ELECTRIC MOTOR
 20 H.P., 460V/3ø/60 HZ
 3600 RPM
 TEFC FRAME

V-800
VERTICAL WET AIR RECEIVER
 MAKE: NORTHWEST
 MAWP: 1379 kPag @ 232°C
 MDMT: -29°C @ 1379 kPag
 120 GAL, 24" ø x 69" LG.
 YEAR BUILT: 2012
 S/N: 684916
 CRN: L4034.5C

V-801
DRY AIR RECEIVER
 MAKE: NORTHWEST
 MAWP: 1034 kPag @ 232°C
 MDMT: -45°C @ 1034 kPag
 2000 USG, 60" ø x 174" LG.
 S/N: 698157
 CRN: R2300.214
 YEAR BUILT: 2012

D-800
HEATLESS AIR DRYER
 MAKE: NORTHWEST
 MODEL: NW100-Y
 115 V/1ø/60 Hz
 MAWP: 1379 kPag
 YEAR BUILT: 2012
 S/N: 130404

F-800
PRE-FILTER
 MAKE: COMPAIR
 MODEL: CAF100E17AG
 124 m³/hr @ 896 kPag
 1724 kPag MAWP
 0.001 MICRON FILTER
 MECHANICAL FLOAT DRAIN

F-801
AFTER FILTER
 MAKE: COMPAIR
 MODEL: CAF100D17AG
 114 m³/hr @ 862 kPag
 1034 kPag MAWP
 1.0 MICRON FILTER
 MANUAL DRAIN

EF-801A/B
EXHAUST FAN


UH-800/801
CATALYTIC HEATER

MCP-800
MAIN CONTROL PANEL

UPS-8001
UNINTERRUPTIBLE POWER SOURCE

XA-8001
NOTE 1

- NOTES:**
1. MOUNT OUTSIDE BUILDING BY MAIN DOOR.
 2. ALL PSV DISCHARGE PIPING TO EXTEND OUTSIDE OF BUILDING ABOVE EAVE HEIGHT.
 3. DRAIN TO SAFETY BUCKET.
 4. REFERRED TO HMI.

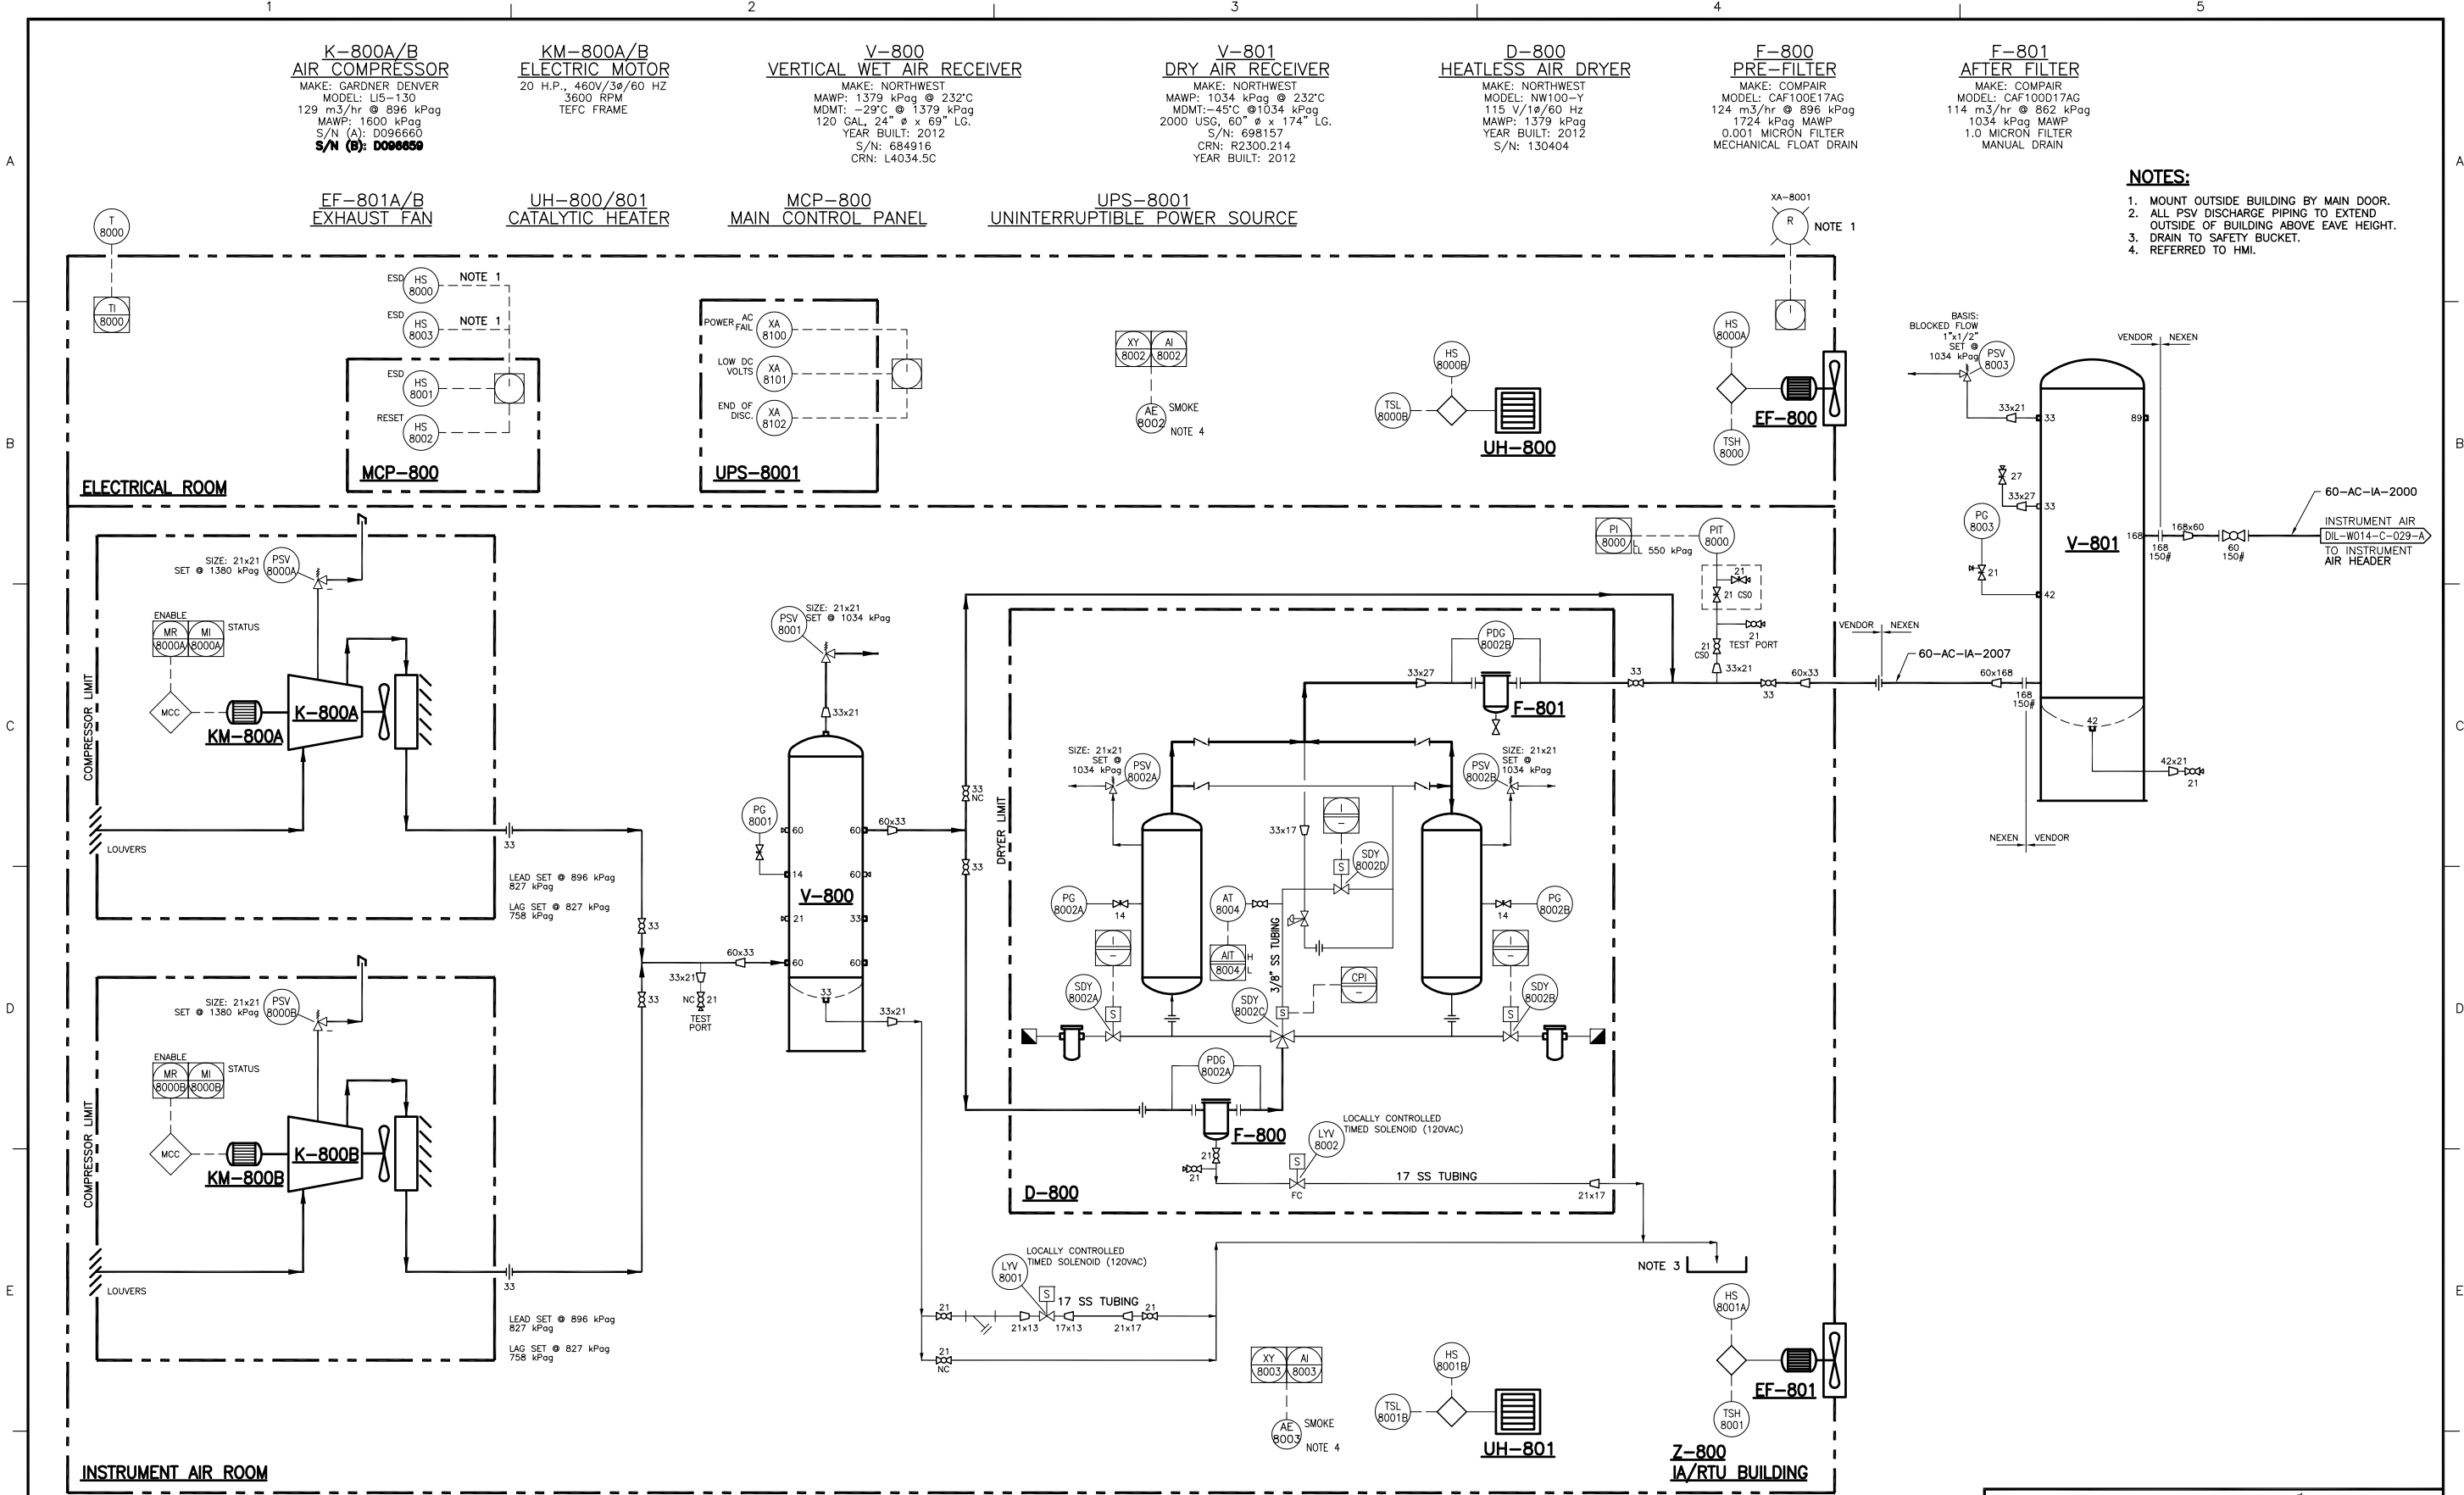

PROJECT REVISION			REFERENCE DRAWINGS			NEXEN REVISION			APPROVAL			PROFESSIONAL STAMP	PERMIT STAMP	
REV No	DATE (YYYY-MM-DD)	DESCRIPTION	DRAFTED BY	CHECKED BY	APPROVED BY	DRAWING No	TITLE	REV No	DATE (YYYY-MM-DD)	DESCRIPTION	DRAFTED BY	CHECKED BY	APPROVED BY	DATE
3	2016-06-24	AS-BUILT (DNS DESIGN - BC0078)									DSK	AM		
2	13-02-25	ISSUED FOR AS-BUILT (SMCI NE11-01381)									OLW	TWJ	DLM	

nexen

**DILLY CREEK WELLSITE
 AIR COMPRESSOR (Z-800) BUILDING
 PIPING AND INSTRUMENTATION DIAGRAM**

PROJECT NUMBER BC0078	LOCATION b-77-H/94-0-8	SCALE N.T.S
EPC NAME SOLARIS - MCI	EPC DRAWING No. -	
NEXEN DWG No DIL-W008-C-032-A	SHEET No 1 OF 1	REV 3